





FLOORING AREA

S.NO	ROOM NAME	SIZE	AREA SQ.FT
PARQUET			
01	INTERNAL AUDIT	10'-4 1/2" X 9'-1 1/2"	96
02	CFO	14'-1" X 10'-6"	145
03	MANAGER HR & ADMIN	8'-0" X 10'-10 1/4"	85
04	MANAGER TACHINAL	8'-0" X 9'-9"	79
05	MANAGER FIANCE	8'-0" X 10'-10"	84
06	M.D ROOM	16'-8" X 20'-0"	232
07	SERVER	13'-0" X 6'-8"	86
08	MEETING ROOM	16'-6" X 10'-4"	172
09	MEETING ROOM 01	24'-5" X 9'-0"	140
10	DISSECTION 4 PERSON	9'-6" X 10'-3"	95
11	BOARD ROOM	21'-9" X 14'-3"	304
12	MEETING ROOM	10'-3" X 14'-3"	145
13	TOTAL AREA OF PARQUET		1663
TILE			
14	CANTEN	11'-0" X 22'-0"	283
15	RECEPTION	25'-1" X 19'-10"	436
16	TOTAL AREA OF TILE		719
CARPET			
17	LOUNGE	14'-9" X 57'-2"	890
18	WORK STATION ROOM	27'-8" X 42'-5"	1002.2
19	TOTAL AREA OF CARPET		1892.2
20	TOTAL AREA OF FLOORING		4281.8




**PETROLEUM
HOUSE
ISLAMABAD**

SCALE=3/16" 02-08-2017

FLOORING LAYOUT
PLL- BLOCK -B


02

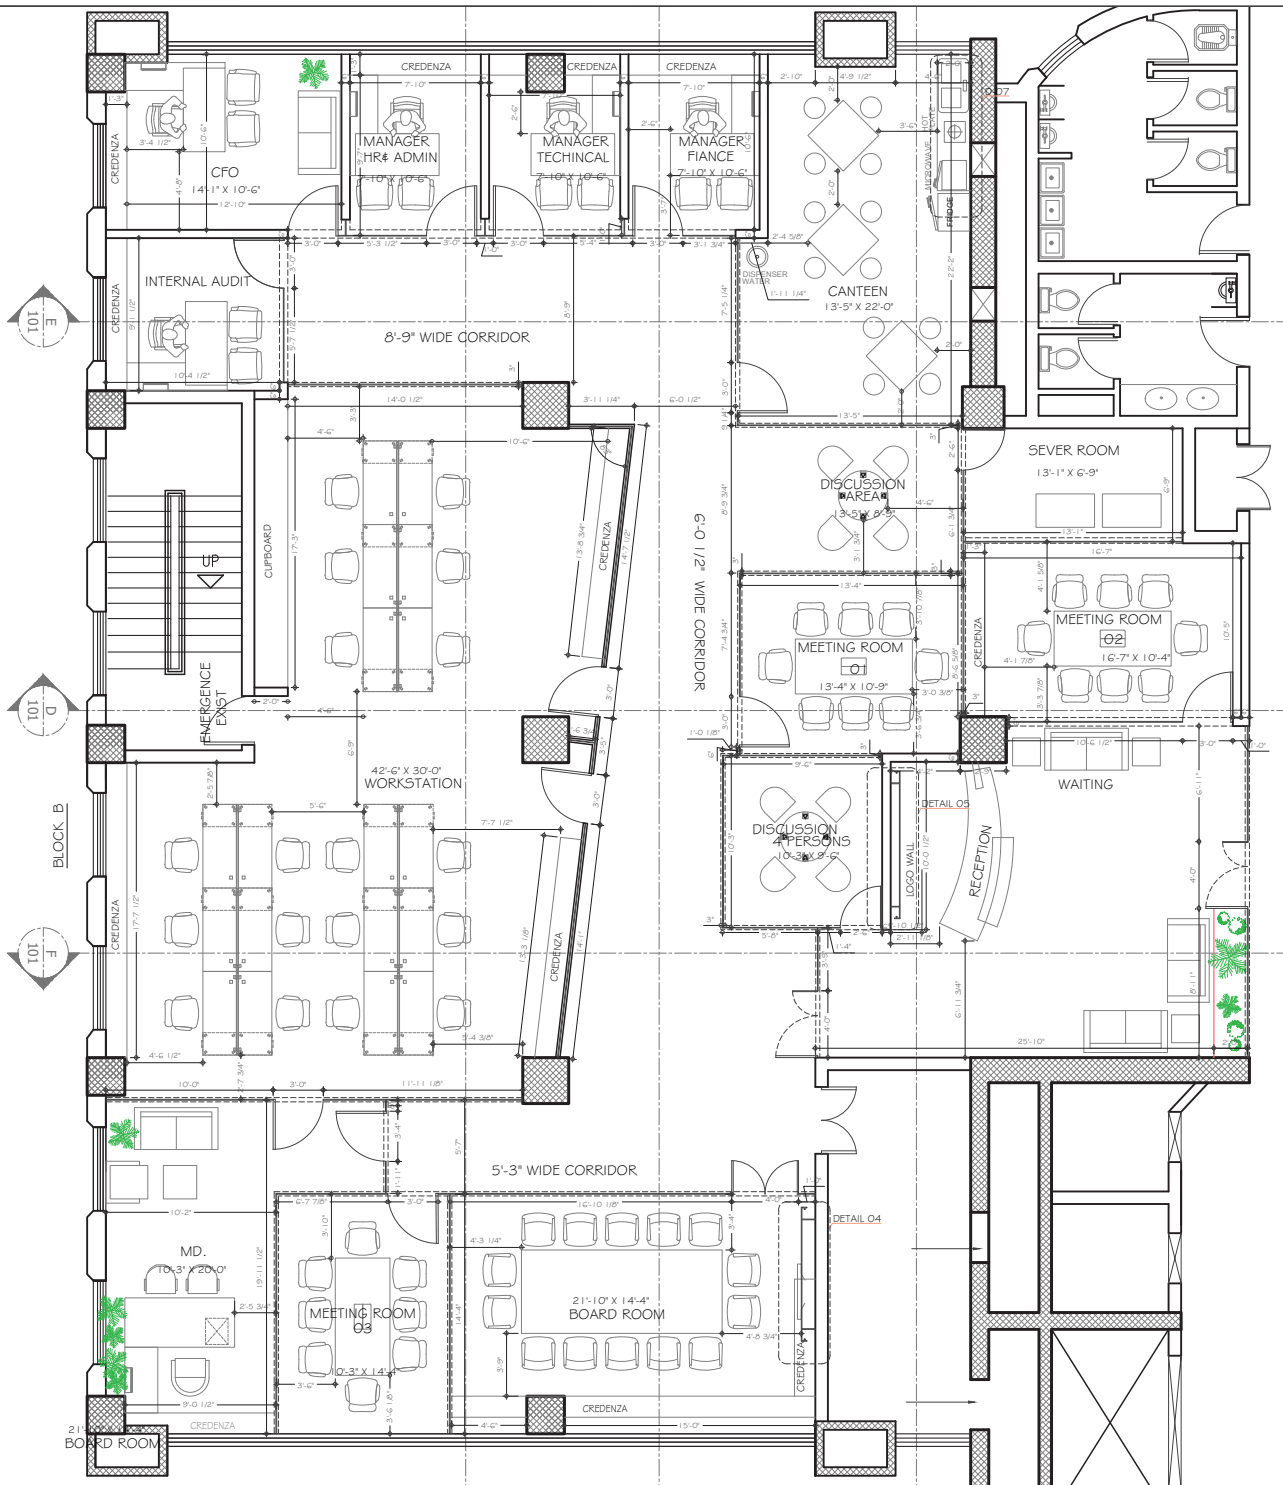



LIGHTING LEGEND	
2' X 2' LED LIGHT	
DOWN LIGHT	
48" TUBE LIGHT	

	PETROLEUM HOUSE ISLAMABAD		04
	SCALE=3/16"	02-08-2017	
	CEILING ILLUMINATION		
	PLL- BLOCK -B		

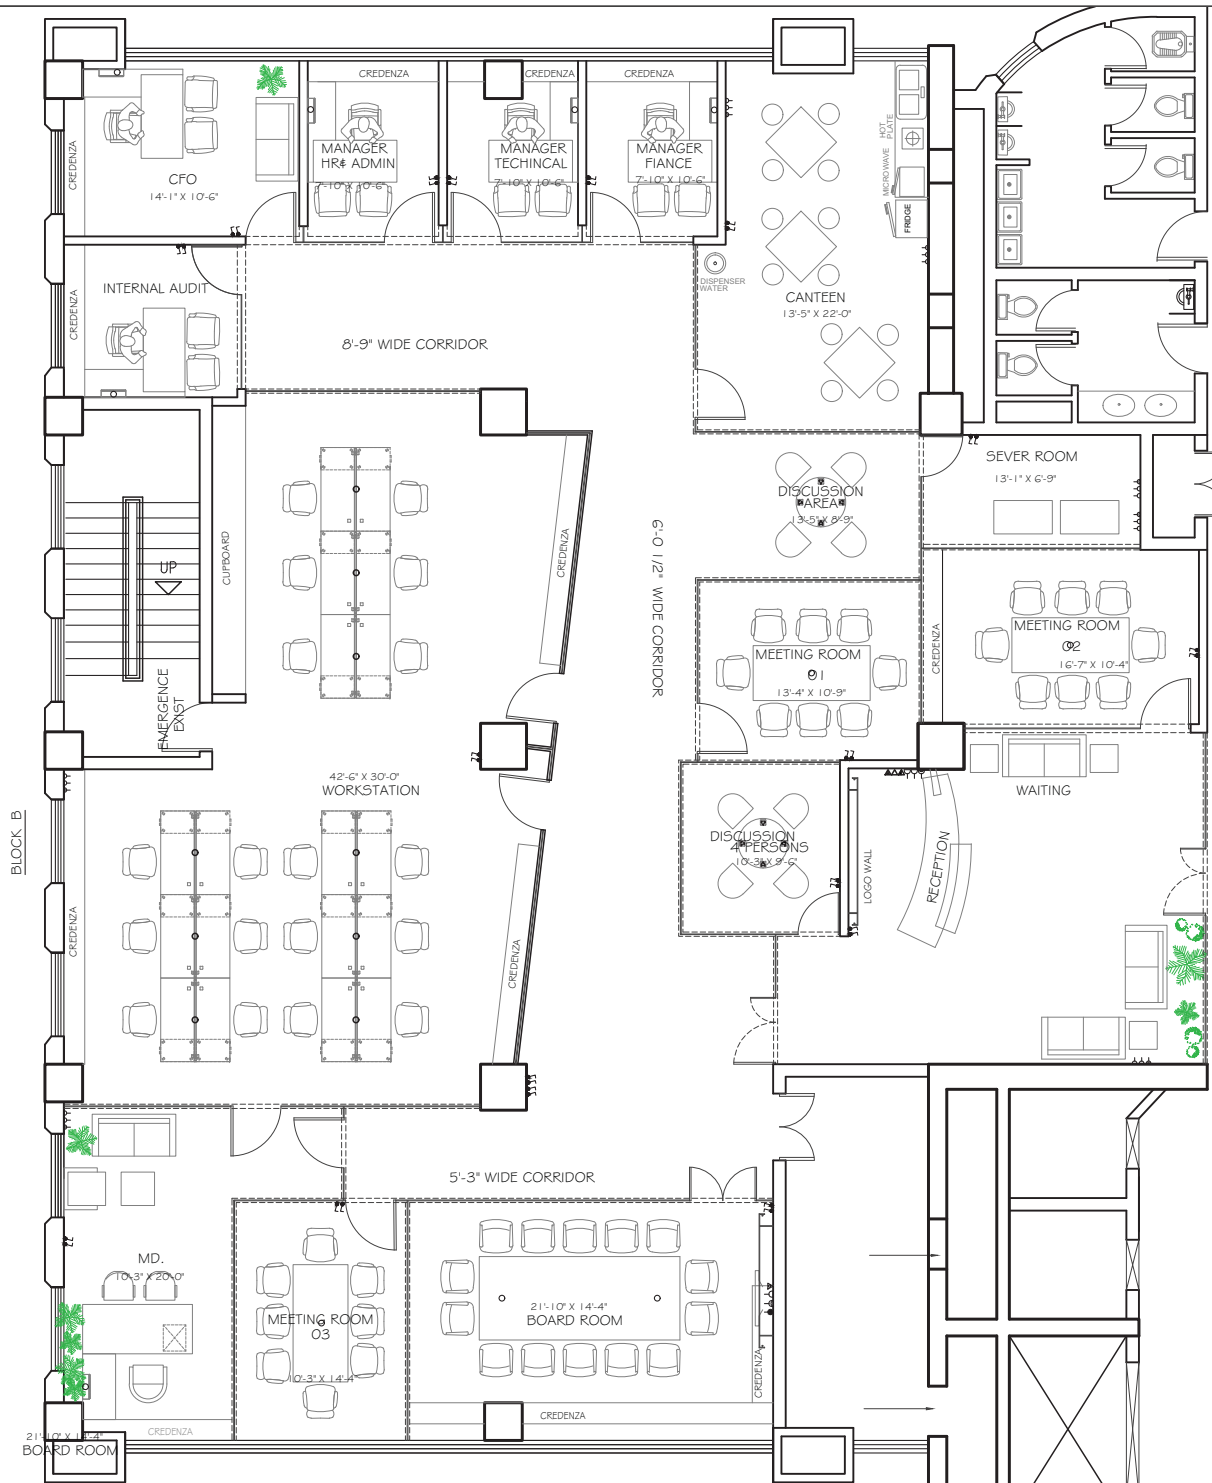

ELECTRICAL LEGEND

- ⎓ WALL SOCKET
- ⎓ POWER SOCKET
- △ TELEPHONE POINT
- ▲ DIRECT PHONE POINT
- △ NETWORK POINT
- LIGHT SWITCH
- CABLE POINT

CABLE SNAKE

CABLE SNAKE WORK STATION

- 2 POWER SOCKET
- 2 WALL SOCKET
- 1 NETWORK POINT
- 1 TELEPHONE POINT

CABLE SNAKE WORK STATION


- 2 POWER SOCKET
- 2 WALL SOCKET
- 2 NETWORK POINT
- 1 TELEPHONE POINT




**PETROLEUM
HOUSE
ISLAMABAD**

SCALE=3/16" 02-08-2017


ELECTRICAL LAYOUT
PLL- BLOCK-B

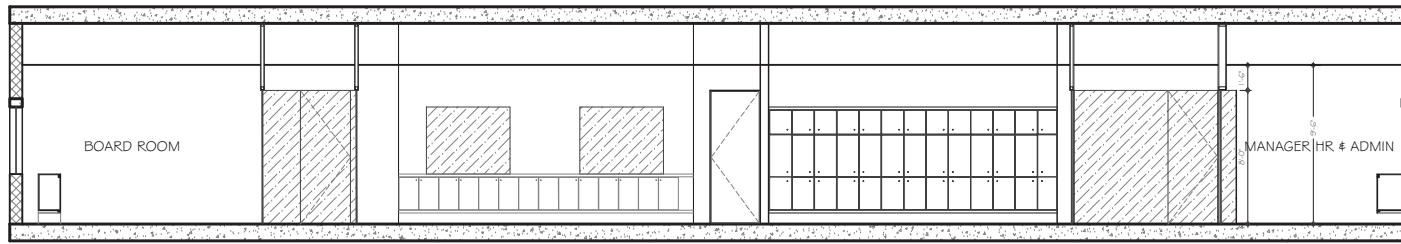


SECTION A-A

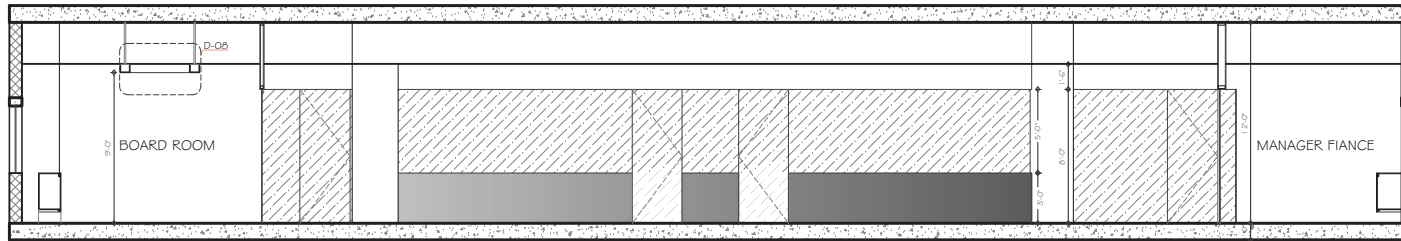







SECTION B-B

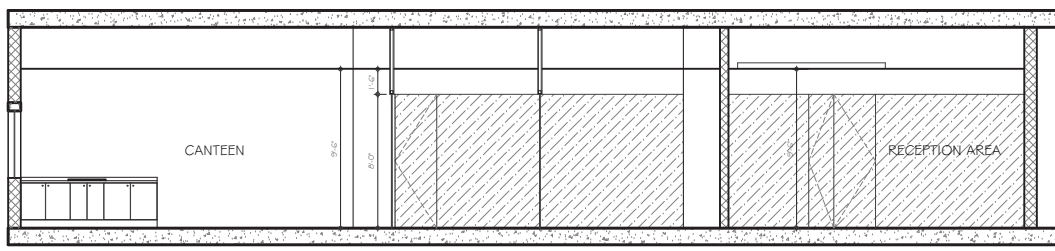


SECTION C-C

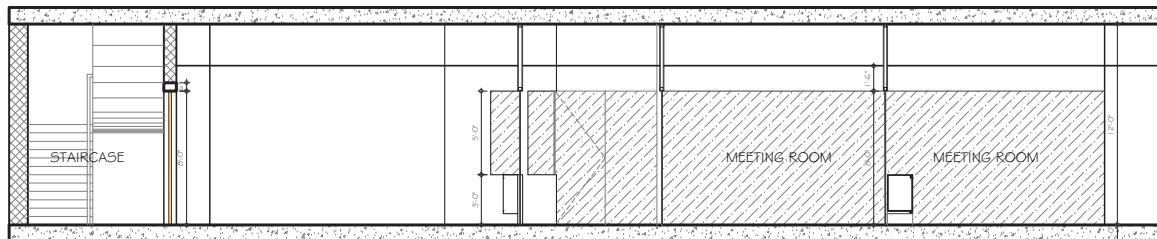




SECTION D-D

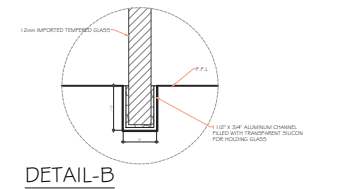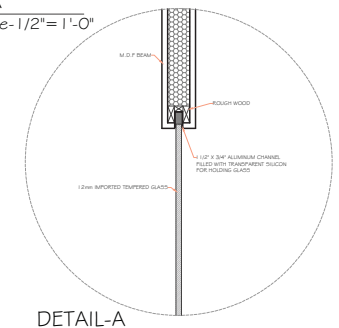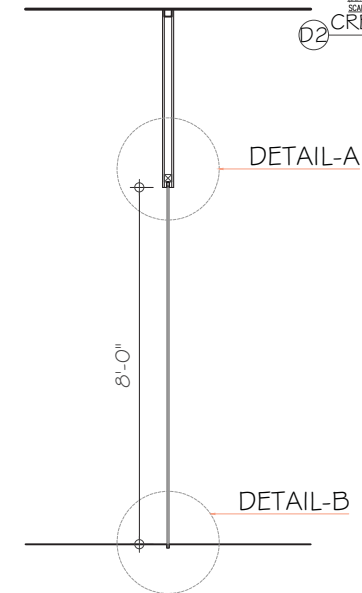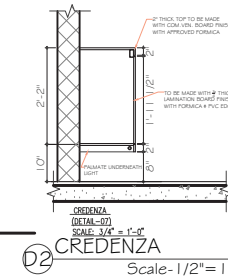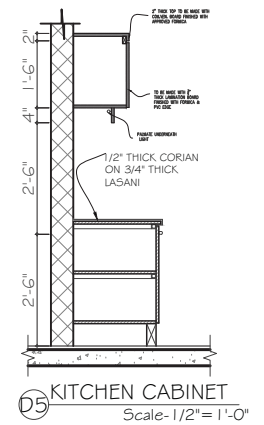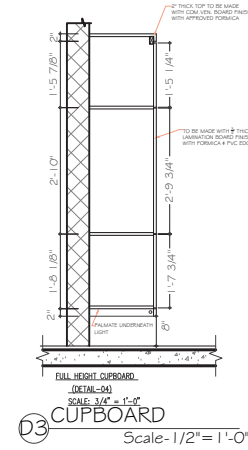



	PETROLEUM HOUSE ISLAMABAD	
	SCALE=3/16"	02-08-2017
	SECTION & DETAILS PLL- BLOCK -B	

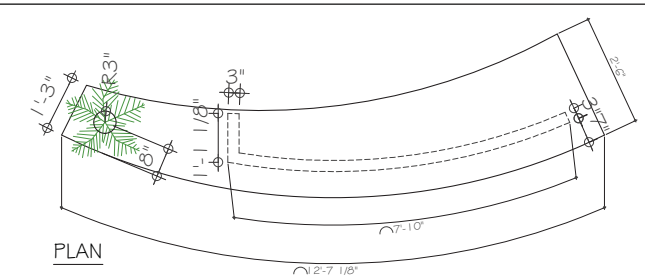


RECEPTION COUNTER
Scale- 1/2" = 1'-0"

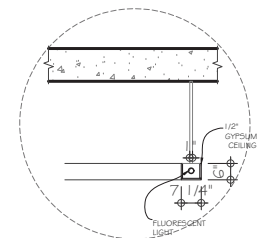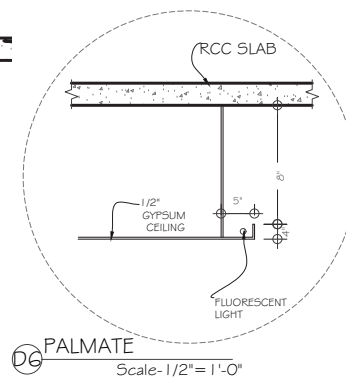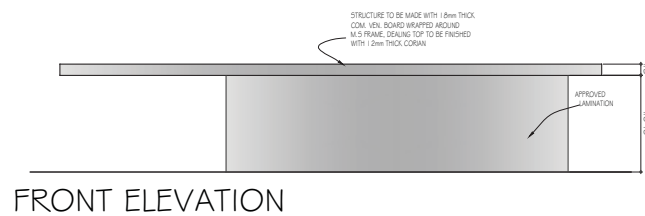


08 BOARD ROOM
Scale - 1/4" = 1'-0"

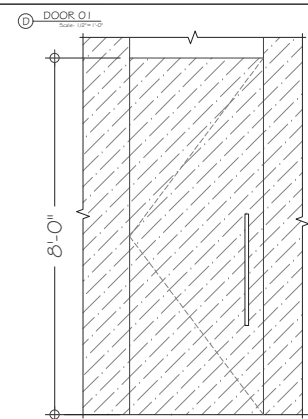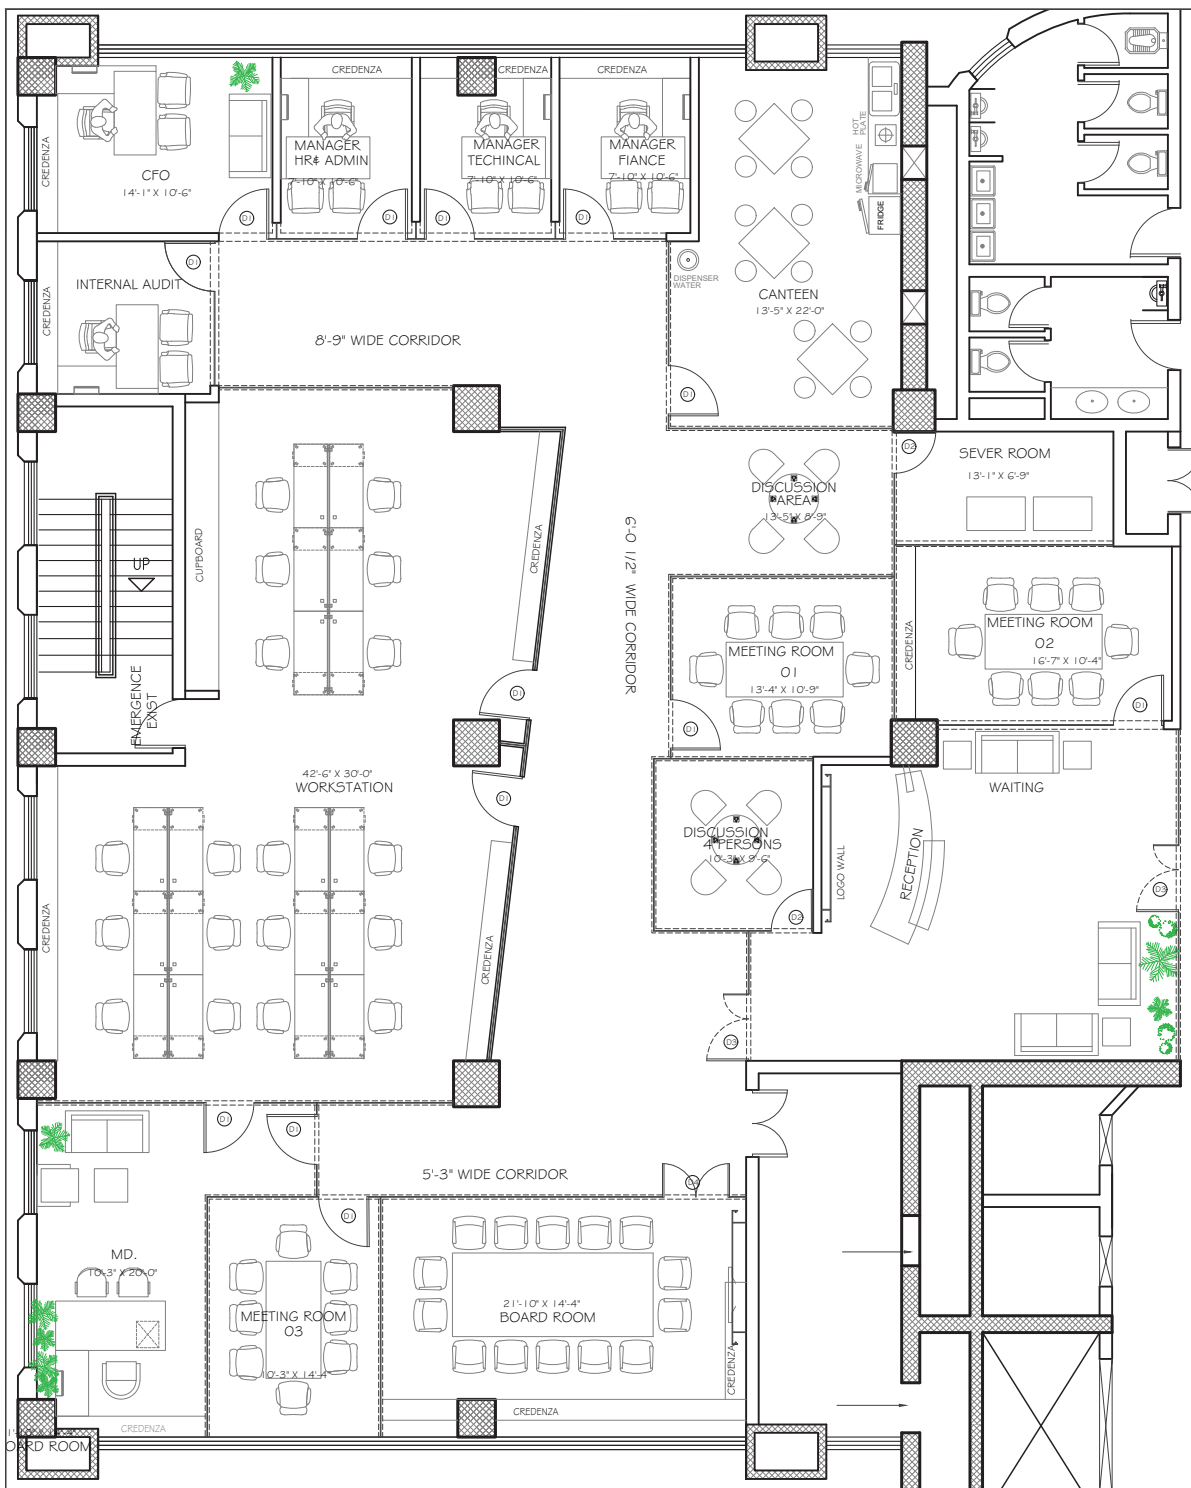


D1 FRONT ELE.

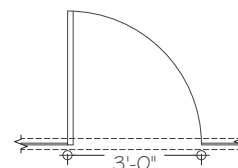


D1 = 3'-0"

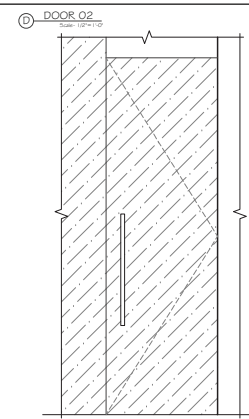


D2 FRONT ELE.

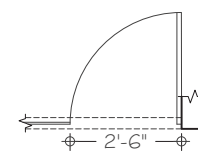


D2 = 2'-6"

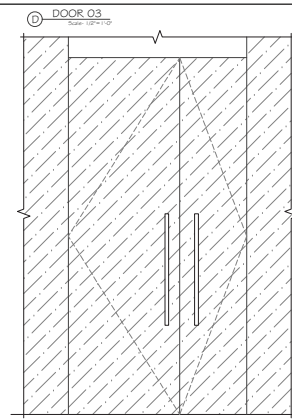


D3 FRONT ELE.

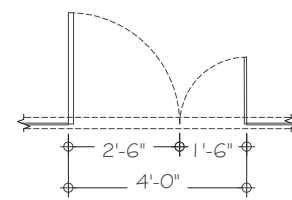

D3 = 4'-0"

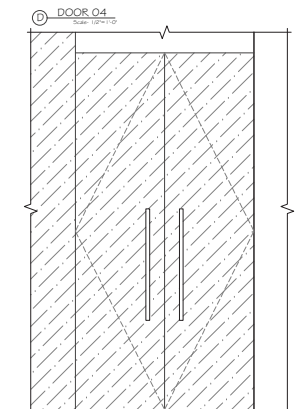

D4 FRONT ELE.

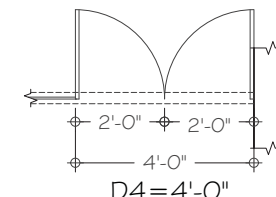

D4 = 4'-0"

S.NO	DOOR NAME	DOOR TYPE	SIZE	QUANTITY
1	(D1)	SWING DOOR	3'-0" X 8'-0"	13
2	(D2)	SWING DOOR	2'-6" X 8'-0"	2
3	(D3)	DOUBLE SWING DOOR	4'-0" X 8'-0"	2
4	(D4)	DOUBLE SWING DOOR	4'-0" X 8'-0"	1